


FIRE PUMP SCHEDULE				
	DESCRIPTION	FLOW RATE (L/min)	PUMP HEAD (bar)	PUMP MOTOR POWER RATING (IN KW)
FFP-01	EXISTING FIXED FIRE PUMP (DUTY)	900 L/min	4 BAR	11 kw
FFP-02	NEW FIXED FIRE PUMP (STANDBY)	900 L/min	4 BAR	11 kw
FUP-01	NEW FS UPFEED PUMP (DUTY) FOR REFERENCE ONLY	60 L/min	6 BAR	2.2 kw
FUP-02	NEW FS UPFEED PUMP (STANDBY) FOR REFERENCE ONLY	60 L/min	6 BAR	2.2 kw

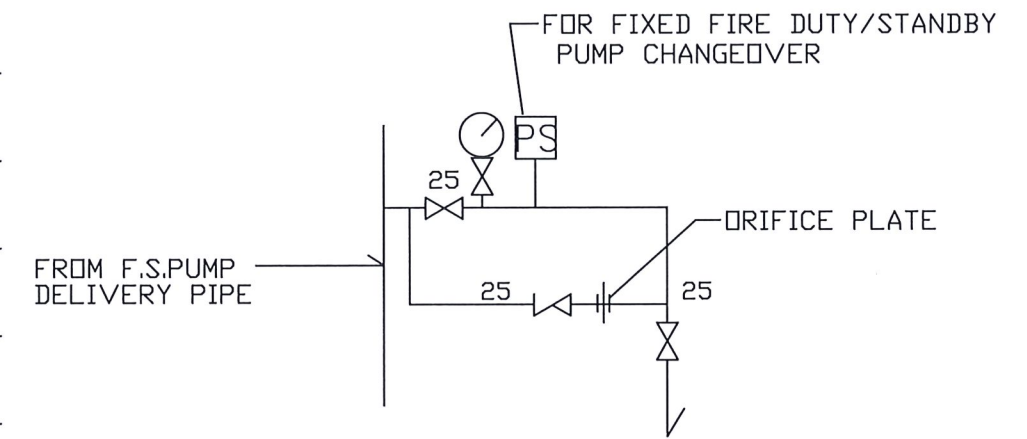

DETAIL C FOR PRESSURE SWITCH CHANGEDOVER ASSEMBLY

FSI CONTRACTOR:

 GLOBAL ENG CONSULTANTS LTD
 ROOM 902, 9/F, SILICON TOWER,
 88 LARCH STREET, TAI KOK TSUI, KLN.
 Email: globalconhk@gmail.com
 Tel: 31881924 Fax: 31862946

PROJECT:

TITLE:
 SCHEMATIC PIPING DIAGRAM FOR FH/HR SYSTEM AND FIRE PUMP SCHEDULE

SCALE: NOT TO SCALE @A3	DRAWN BY: K.H.
DATE: 30-01-2020	DESIGNED BY: T.W.
DWG. NO: FS/03	CHECKED BY: T.W.
CONTRACT NO.:	SHEET:
REVISION:	A

SCHEMATIC PIPING DIAGRAM FOR FH/HR SYSTEM