



GROUND FLOOR PLAN

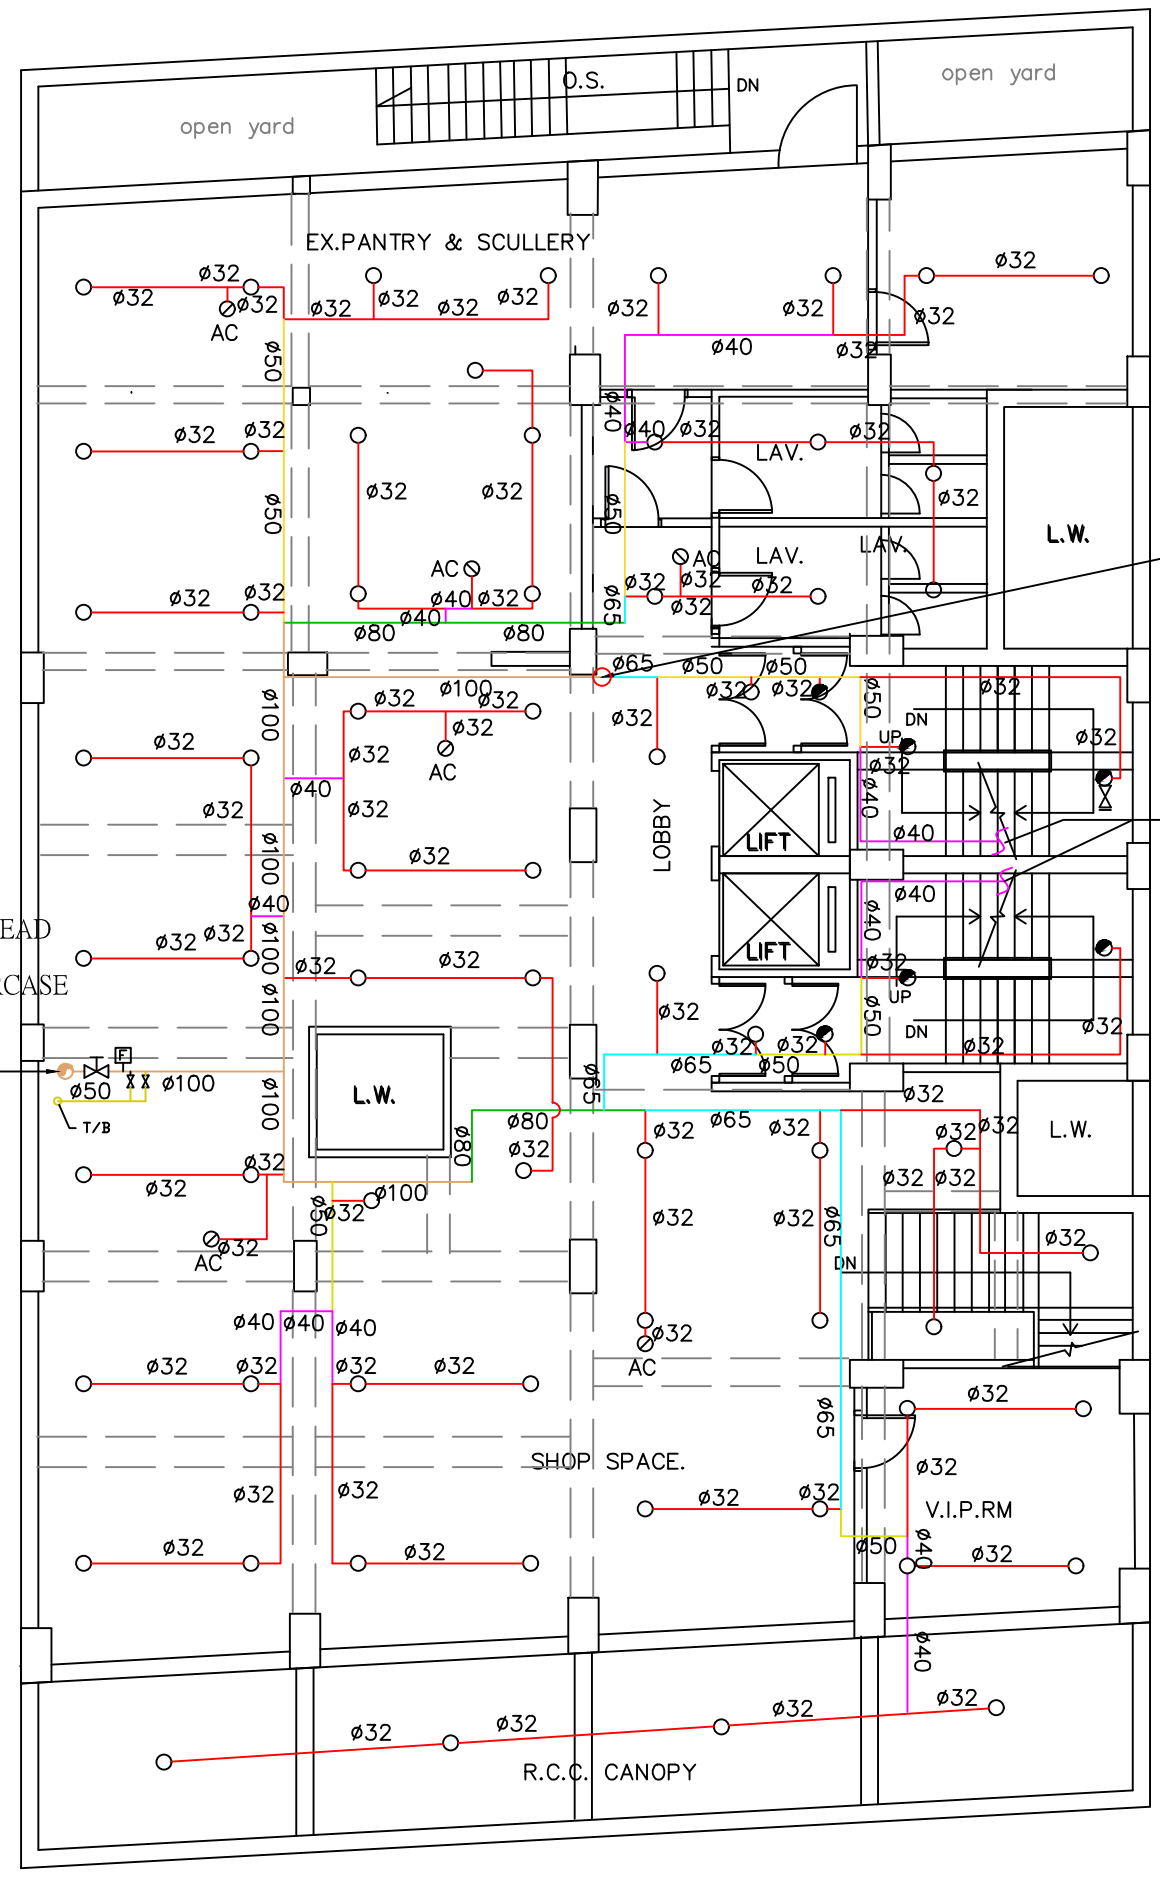

FIRST FLOOR PLAN

FSI CONTRACTOR:	
 GLOBAL ENG CONSULTANTS LTD ROOM 902, 9/F, SILICON TOWER, 88 LARCH STREET, TAI KOK TSUI, KLN. Email: globalconhk@gmail.com Tel: 31881924 Fax: 31862946	
PROJECT:	
TITLE: SPRINKLER LAYOUT PLAN FOR GROUND FLOOR AND FIRST FLOOR	
SCALE: 1 : 100 @A3	DRAWN BY: K.H.
DATE: 30-01-2020	DESIGNED BY: T.W.
DWG. NO: FS/12	CHECKED BY: T.W.
CONTRACT NO.:	SHEET:
REVISION: A	